


1 2 3 4 5 6 7 8

A
B
C
D
E
F

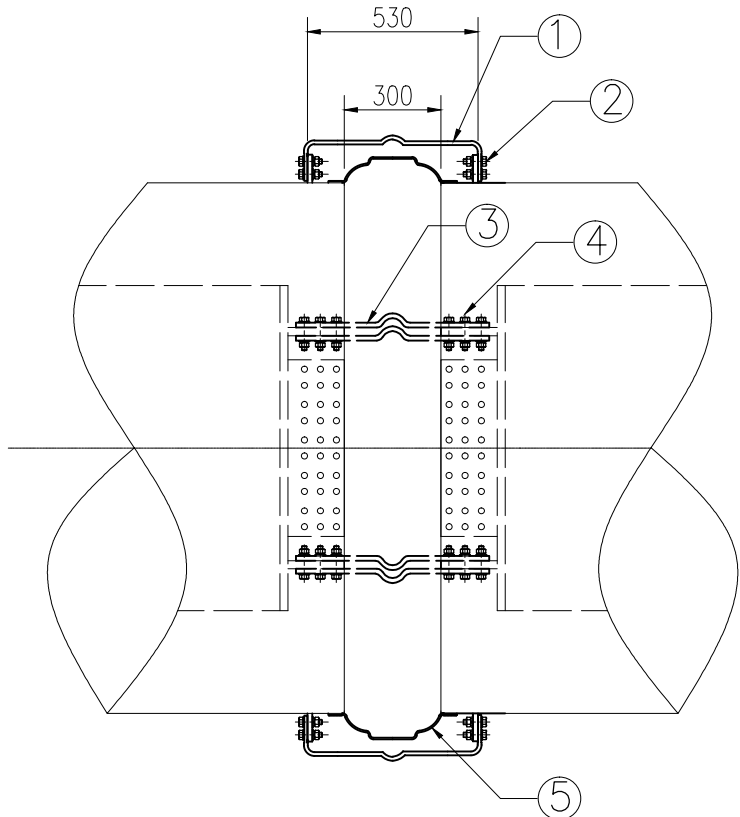

Note:
1. This structure is used
between IPB and IPB
or
between IPB and GTE

5	FMT-5.1650	橡胶波纹管装配 Assembly of Rubber Bellow		1 set				
4		不锈钢螺栓装配M16×85 BOLT M16×85		300set				
3	TJB-LXSY-06-02	软连接 Flexible joint		40set				
2	GB5782	不锈钢螺栓装配M12×60 BOLT M12×60		450set				
1	TJB-LXSY-06-01	软连接 Flexible joint		40set				
序号 NO.	零件号 PART NO.	名称 DESCRIPTION	材料 MAT'L	数量 QTY.	单重 重量 kg	备注 REMARKS		
Daqo 江苏大全封闭母线有限公司 JIANGSU DAQO ENCLOSED BUSBAR SYSTEMS CO.,LTD			设计阶段: DESIGN STAGE:		Detailed design			
工程名称: TANJUNG JATI B EXPANSION (JAWA-4) PROJECT: COAL FIRED STEAM POWER PLANT 2 x 1,000 MW			设计编号: ERP CODE:		F02494			
设计: DSGD:	校核: CHKD:	图样名称 DESCRIPTION:			Removable connection structure		页码: 1/1	
审核: RWMD:	批准: APPRD:	图号 DWG No.: TJB-LXSY-06						
日期: DATE:	比例: SCALE: 1:1	版本: REV: C						

1 2 3 4 5 6 7 8