



VIEW A-A

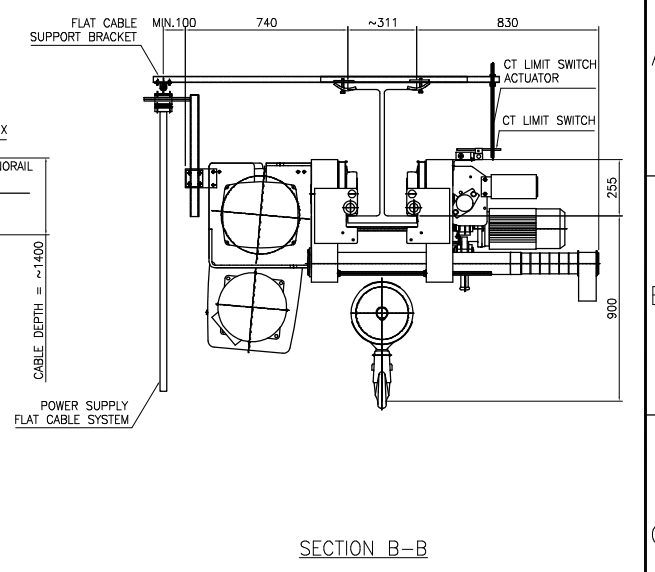

SECTION B-B

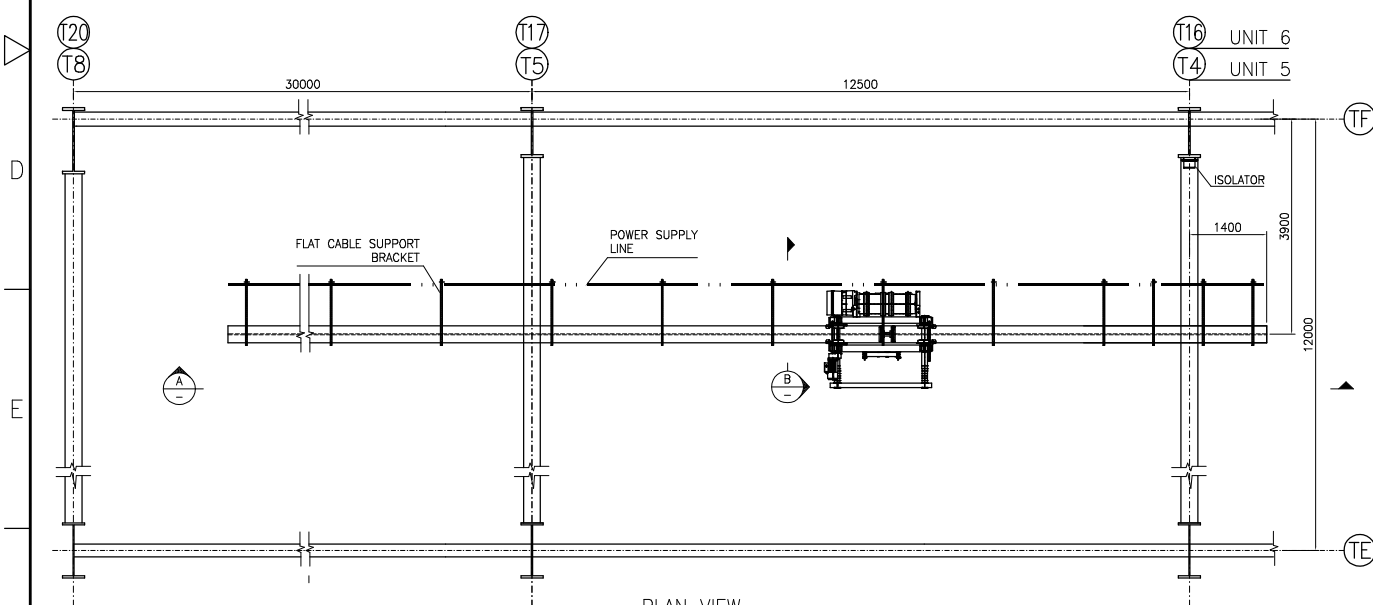

PLAN VIEW

LOADING DATA:
 WEIGHT OF WIRE ROPE HOIST=1600kg
 MAX. WHEEL LOAD=4100kg
 (4 NOS. WHEELS)

REFERENCE:
 ARRANGEMENT DRAWING MONORAIL & HOIST FOR BFPT
 (TJB56-L1-OFF-C-SMM-M-DGA-3153)

KKS NO.
 50 SMM10 AE 030 / ELECTRIC HOIST FOR BFPT (FOR UNIT-5)
 60 SMM10 AE 030 / ELECTRIC HOIST FOR BFPT (FOR UNIT-6)

OFFICIAL REVISION NUMBER:2

QUANTITY	UNIT 5: 1, UNIT 6: 1	TOTAL: 2 UNITS
SAFE WORKING LOAD/ HOIST RATED CAPACITY	12500 KG	
HOIST TYPE	SH6063-12 4/2-1 L3	
HOIST CLASS	FEM 1Am (M4)	
HOIST MAKE/COUNTRY	STAHL CRANESYSTEMS / GERMANY	
HOISTING SPEED	6.3/1.0 M/MIN	15.0/2.5 kW
CROSS TRAVEL	20/5 M/MIN	0.55/0.13 kW
CONTROL TYPE	RADIO REMOTE CONTROL	
CONTROL VOLTAGE	48V	
POWER SUPPLY	380V / 3PH / 50HZ	
MONORAIL LENGTH	41100 mm	
LIFTING HEIGHT	12470 mm	

ALL DIMENSIONS IN MILLIMETRE UNLESS OTHERWISE SPECIFIED

g	20-01-2022	ISSUE FOR AS-BUILT	E.B.NC	S.P.KAM	M.W.TUNG
f	28-05-2019	REVISED AS PER COMMENTS	E.B.NC	S.P.KAM	M.W.TUNG
e	25-04-2019	REVISED AS PER COMMENTS	E.B.NC	S.P.KAM	M.W.TUNG
d	18-04-2019	REVISED AS PER COMMENTS	E.B.NC	S.P.KAM	M.W.TUNG
c	11-03-2019	REVISED AS PER COMMENTS	E.B.NC	S.P.KAM	M.W.TUNG
b	12-02-2019	REVISED AS PER COMMENTS	E.B.NC	S.P.KAM	M.W.TUNG
a	22-01-2019	ISSUE FOR APPROVAL	E.B.NC	S.P.KAM	M.W.TUNG
REV. NO.	DATE	DETAILS	REV. BY	CHECKED BY	APPR. BY

SCALE: N.T.S. A3

DWN E.B.NC	PROJECT: TANJUNG JATI B EXPANSION (JAWA-4) COAL FIRED STEAM POWER PLANT 2x1000MW PROJECT
DATE 22-01-2019	CUSTOMER: PT. BHUMI JATI POWER
CH'D S.P.KAM	TITLE: 12.5t x 12.47m LIFTING ELECTRIC HOIST FOR BFPT (FOR UNIT-5) & BFPT (FOR UNIT-6)
DATE 22-01-2019	OUTLINE DRAWING FOR MAINTENANCE HOIST
APR. M.W.TUNG	DOC NO.: -
DATE 22-01-2019	DWG NO.: WH9299-G
SHEET 1/2	REV. g